


# 300 SERIES MEETING ROOMS

SOUTH LOBBY

REFLECTED CEILING PLAN

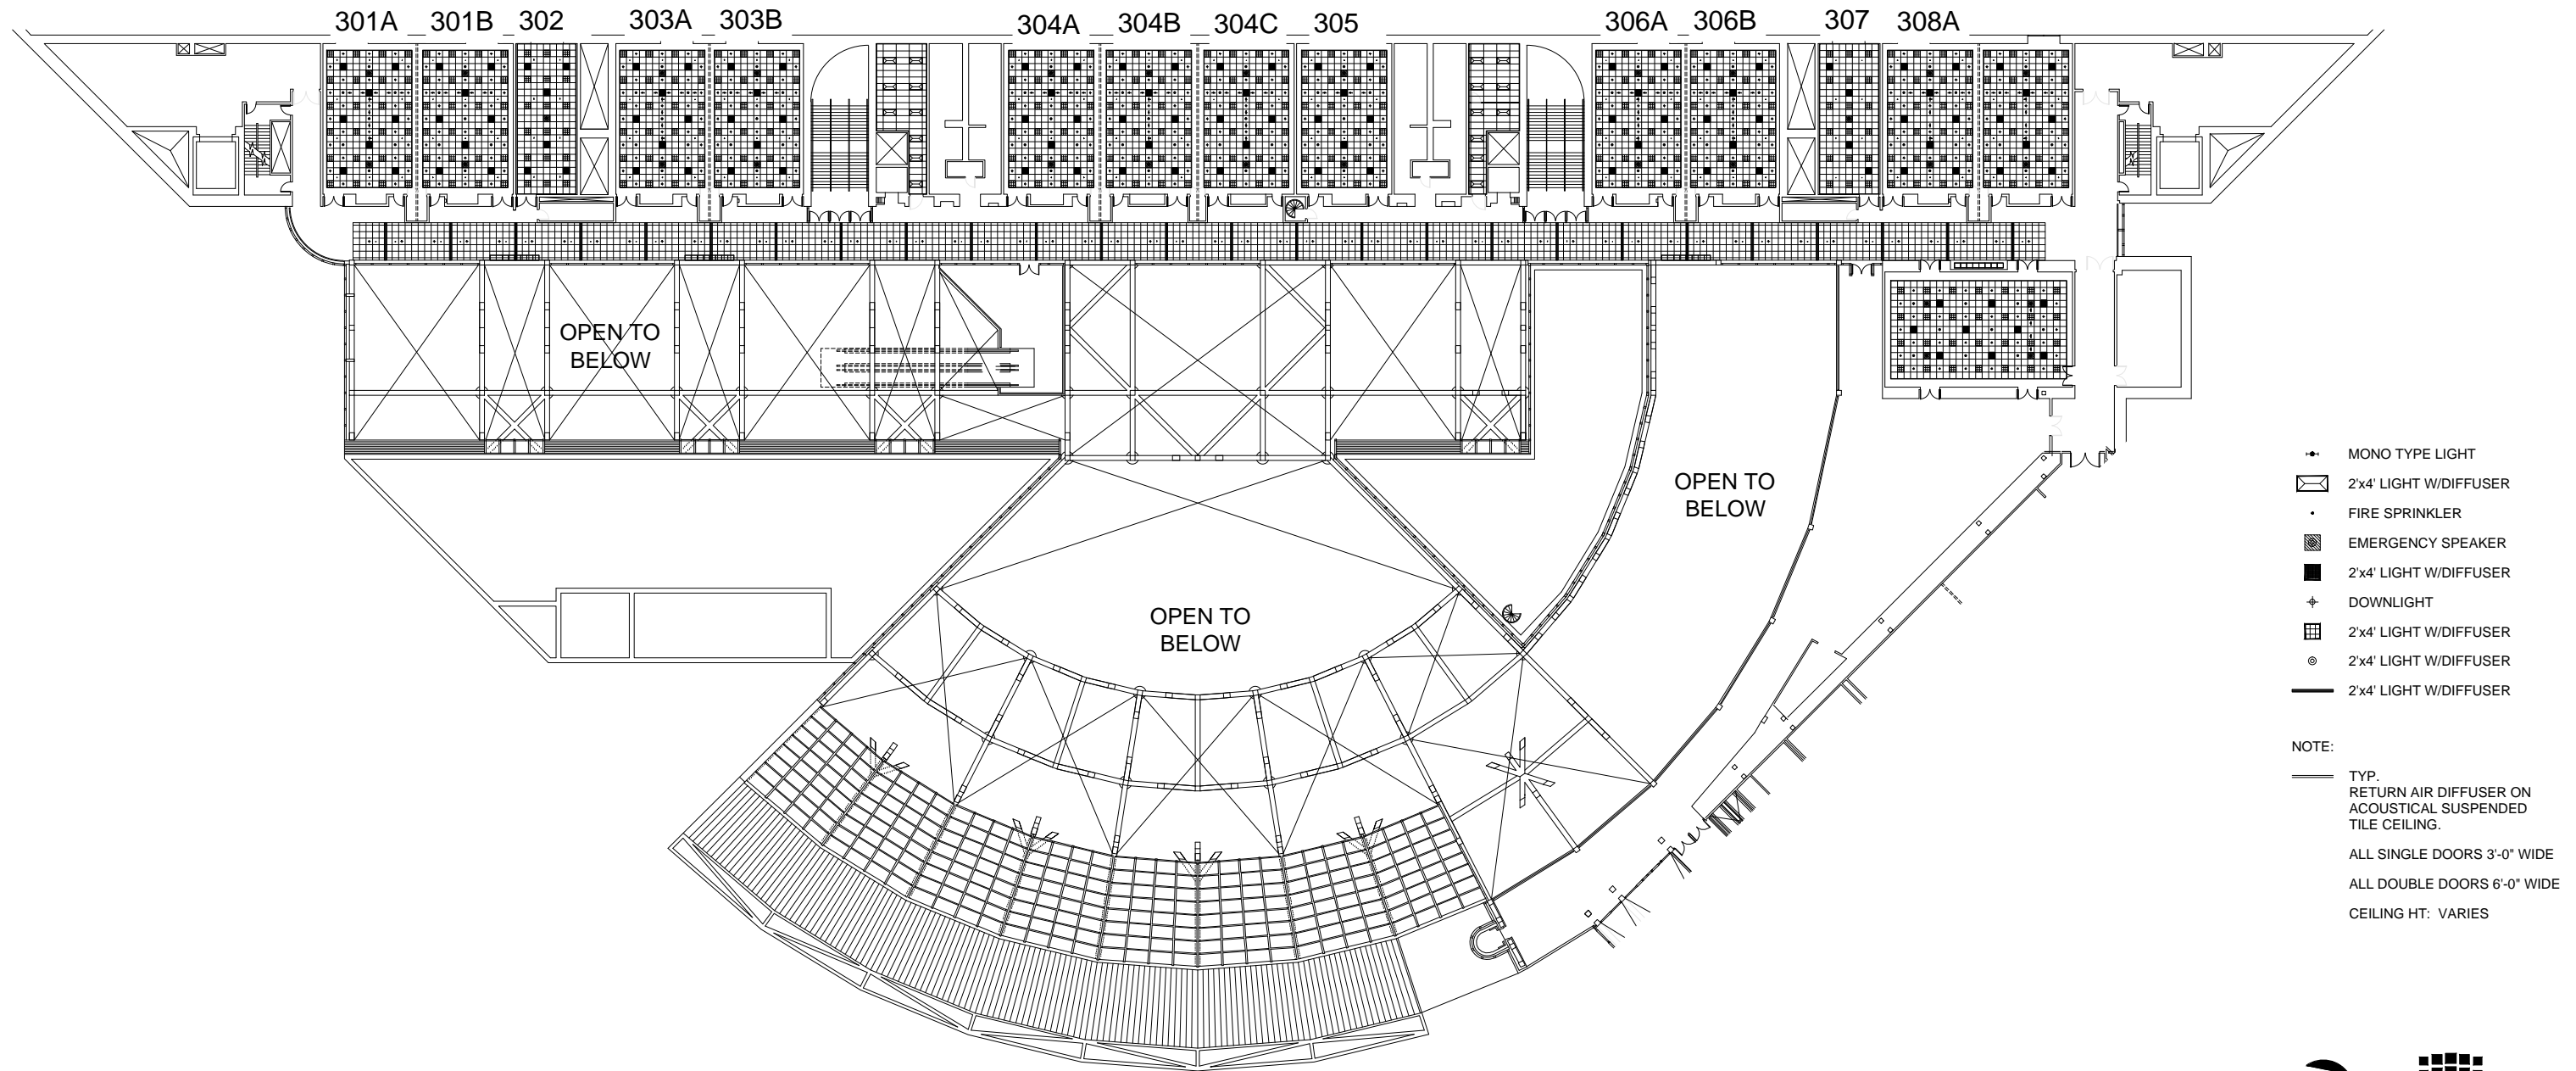

- MONO TYPE LIGHT
- ⊠ 2'x4' LIGHT W/DIFFUSER
- FIRE SPRINKLER
- EMERGENCY SPEAKER
- 2'x4' LIGHT W/DIFFUSER
- ⊕ DOWNLIGHT
- ⊞ 2'x4' LIGHT W/DIFFUSER
- ⊙ 2'x4' LIGHT W/DIFFUSER
- 2'x4' LIGHT W/DIFFUSER

NOTE:

— TYP.  
RETURN AIR DIFFUSER ON  
ACOUSTICAL SUSPENDED  
TILE CEILING.

ALL SINGLE DOORS 3'-0" WIDE  
ALL DOUBLE DOORS 6'-0" WIDE  
CEILING HT: VARIES

NORTH

Los Angeles  
Convention Center

SCALE: 1"=50'